


SCHEMATIC DRAWING IS HIGHLY SIMPLIFIED. FOR DETAILS ON ALL VALVES, INSTRUMENTS, PIPE AND INSULATION SPECS SEE P&ID DRAWING 186512-000-PR-03-040301.

DEFICIENT ATMOSPHERE SENSORS IN PITS AND NEAR PURGE VENT.

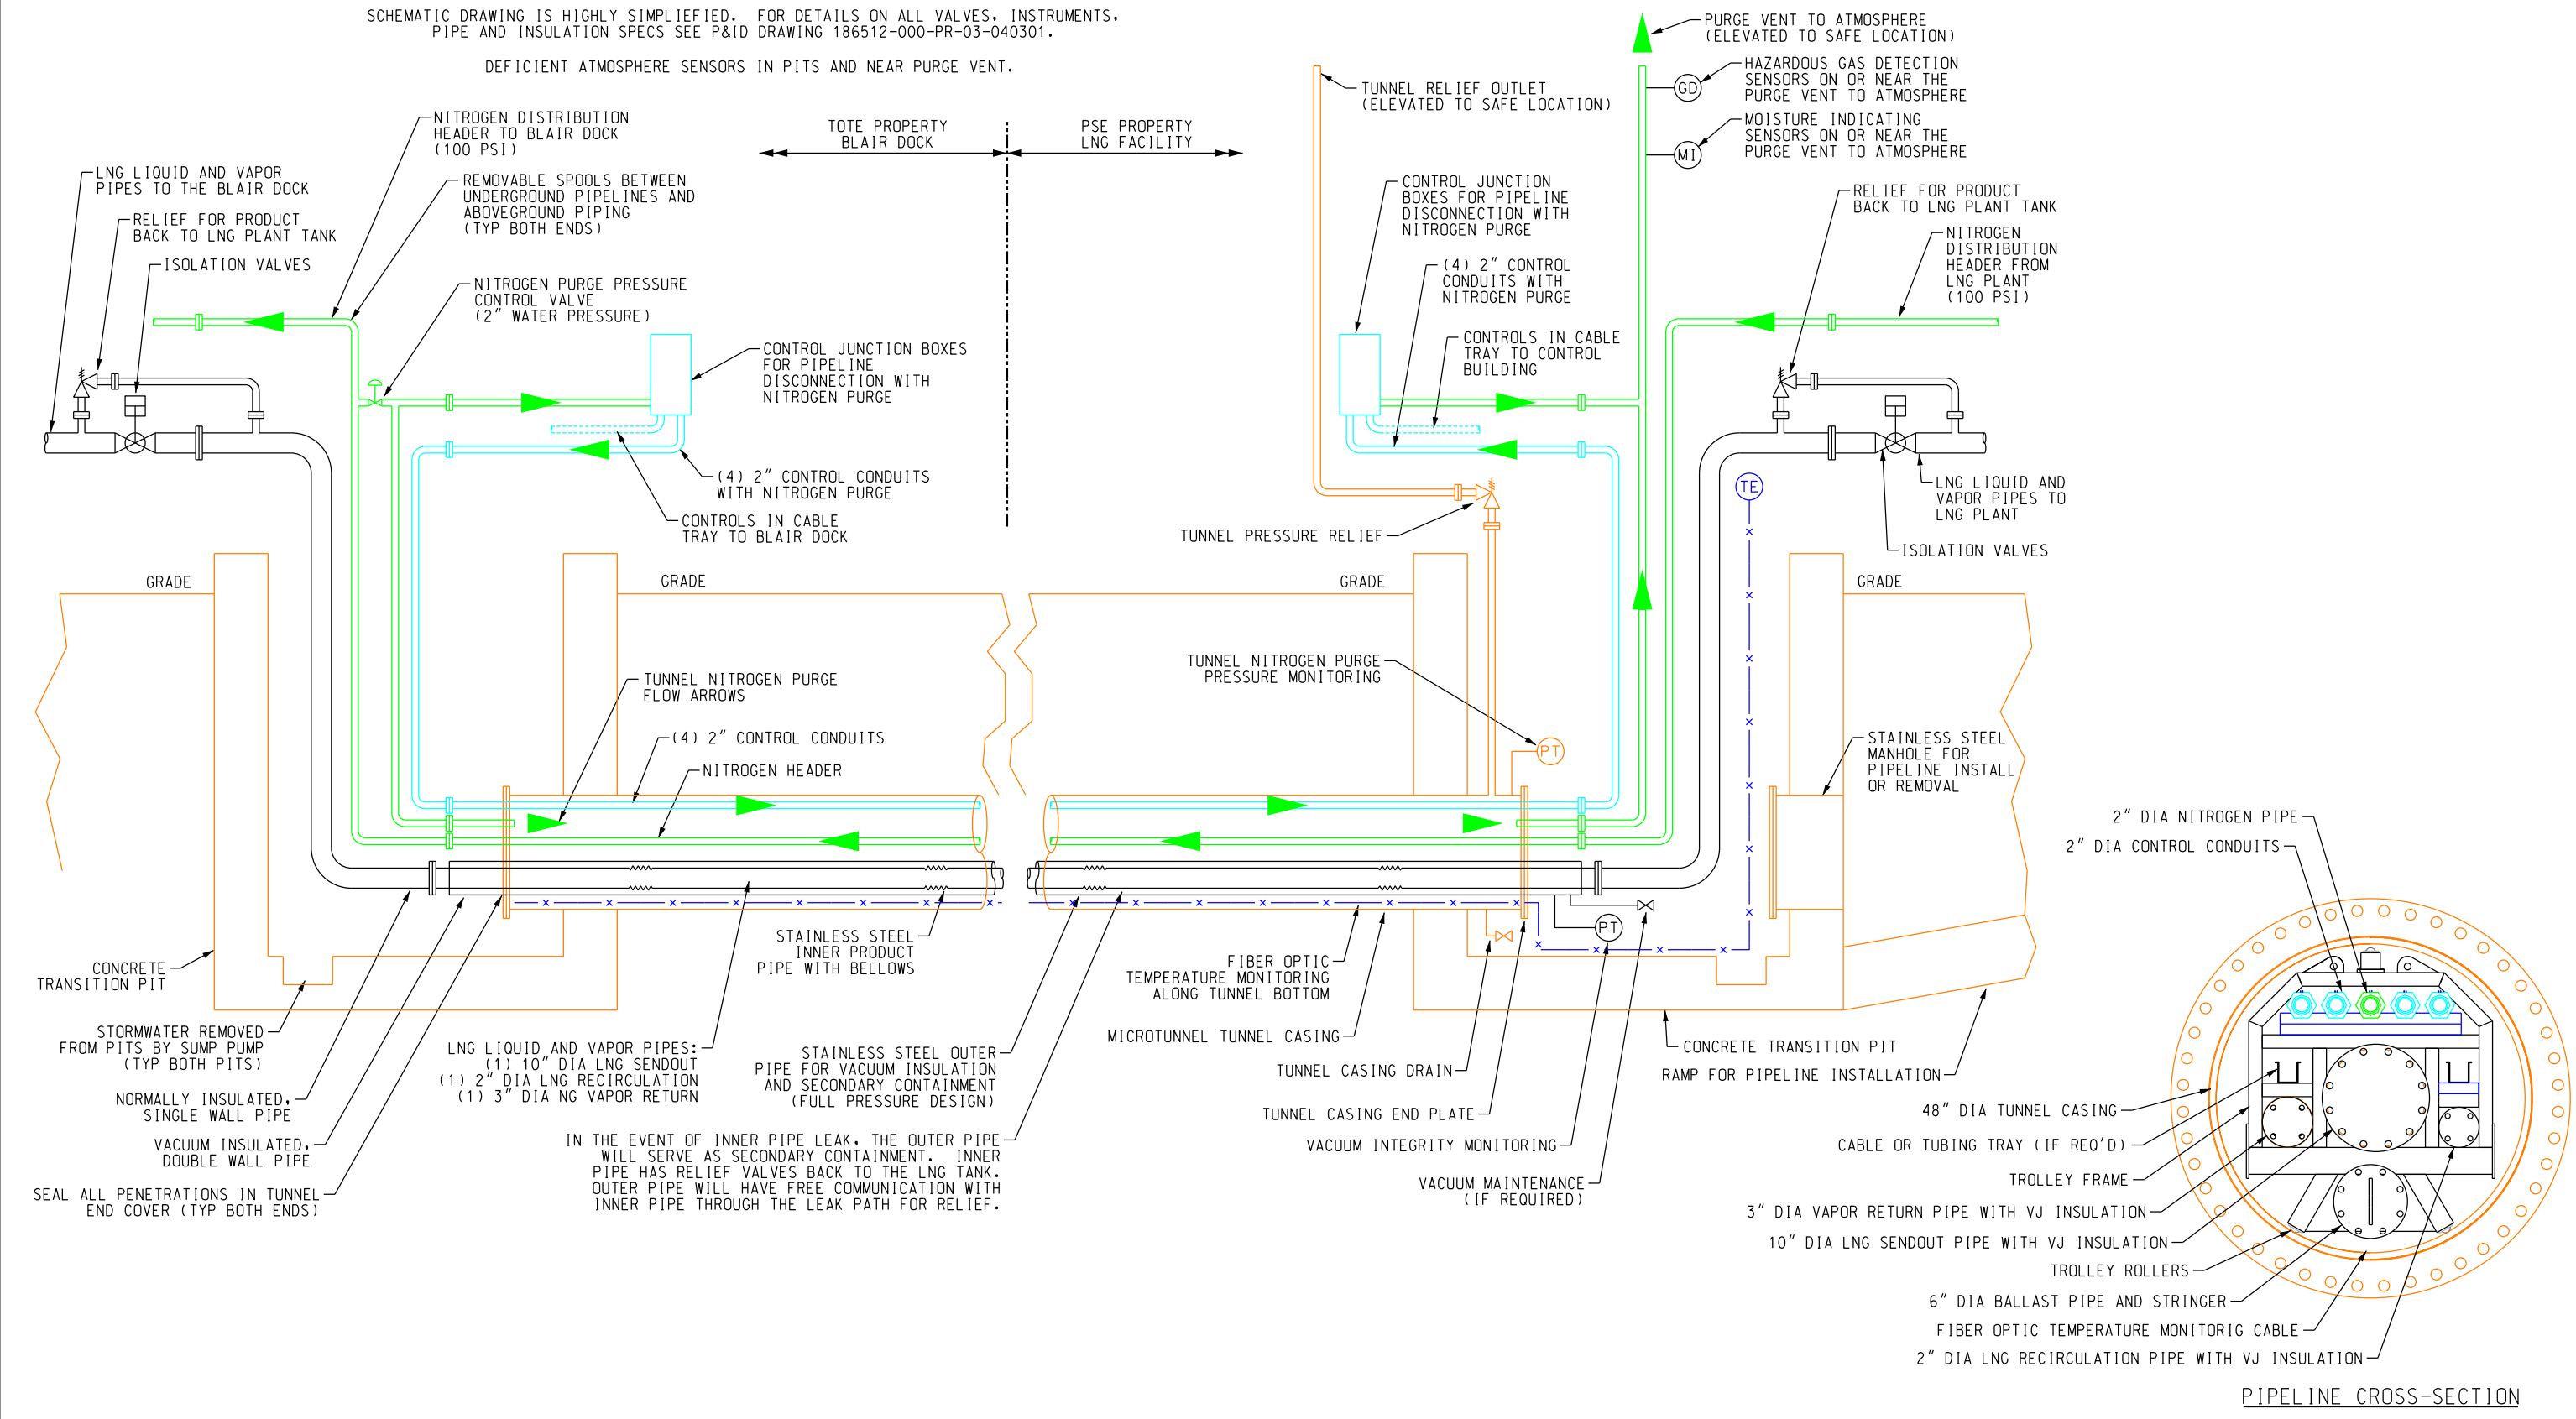

PIPELINE CROSS-SECTION

NOTES

-	-	-	-	-	-	-	-
-	-	-	-	-	-	-	-
-	-	-	-	-	-	-	-
-	-	-	-	-	-	-	-
C	ISSUED FOR INFORMATION	DAS	MES	MES	21APR15		
B	ISSUED FOR INFORMATION	DAS	MES	MES	09APR15		
NO.	REVISION	DRAWN	CK'D	APPD	DATE	DRAWN: DAS	CK'D: MES



THIS DOCUMENT IS THE PROPERTY OF CHICAGO BRIDGE & IRON COMPANY ("CB&I"). IT MAY CONTAIN INFORMATION DESCRIBING TECHNOLOGY OWNED BY CB&I AND DEEMED TO BE COMMERCIALY SENSITIVE. IT IS TO BE USED ONLY IN CONNECTION WITH WORK BEING PERFORMED BY CB&I. REPRODUCTION IN WHOLE OR IN PART FOR ANY PURPOSE OTHER THAN WORK PERFORMED BY CB&I IS FORBIDDEN EXCEPT BY EXPRESS WRITTEN PERMISSION OF CB&I. IT IS TO BE SAFEGUARDED AGAINST BOTH DELIBERATE AND INADVERTENT DISCLOSURE TO ANY THIRD PARTY.

LNG PIPELINE SIMPLIFIED SCHEMATIC
TACOMA LNG
TACOMA, WA

FOR: PUGET SOUND ENERGY

PROJECT NO: 186512 LNG NO: 000-CV-26-025101 REV: C

H: / Project / 186512 / 05 Engineering / 05.13 Drawings / 05.13.02 Siterwork / 186512-000-CV-26-025101.dgn iDocs folder 14.4.4.9